



BUILDING "B" - FIRE PROTECTION
Scale: 1/8"=1'-0"

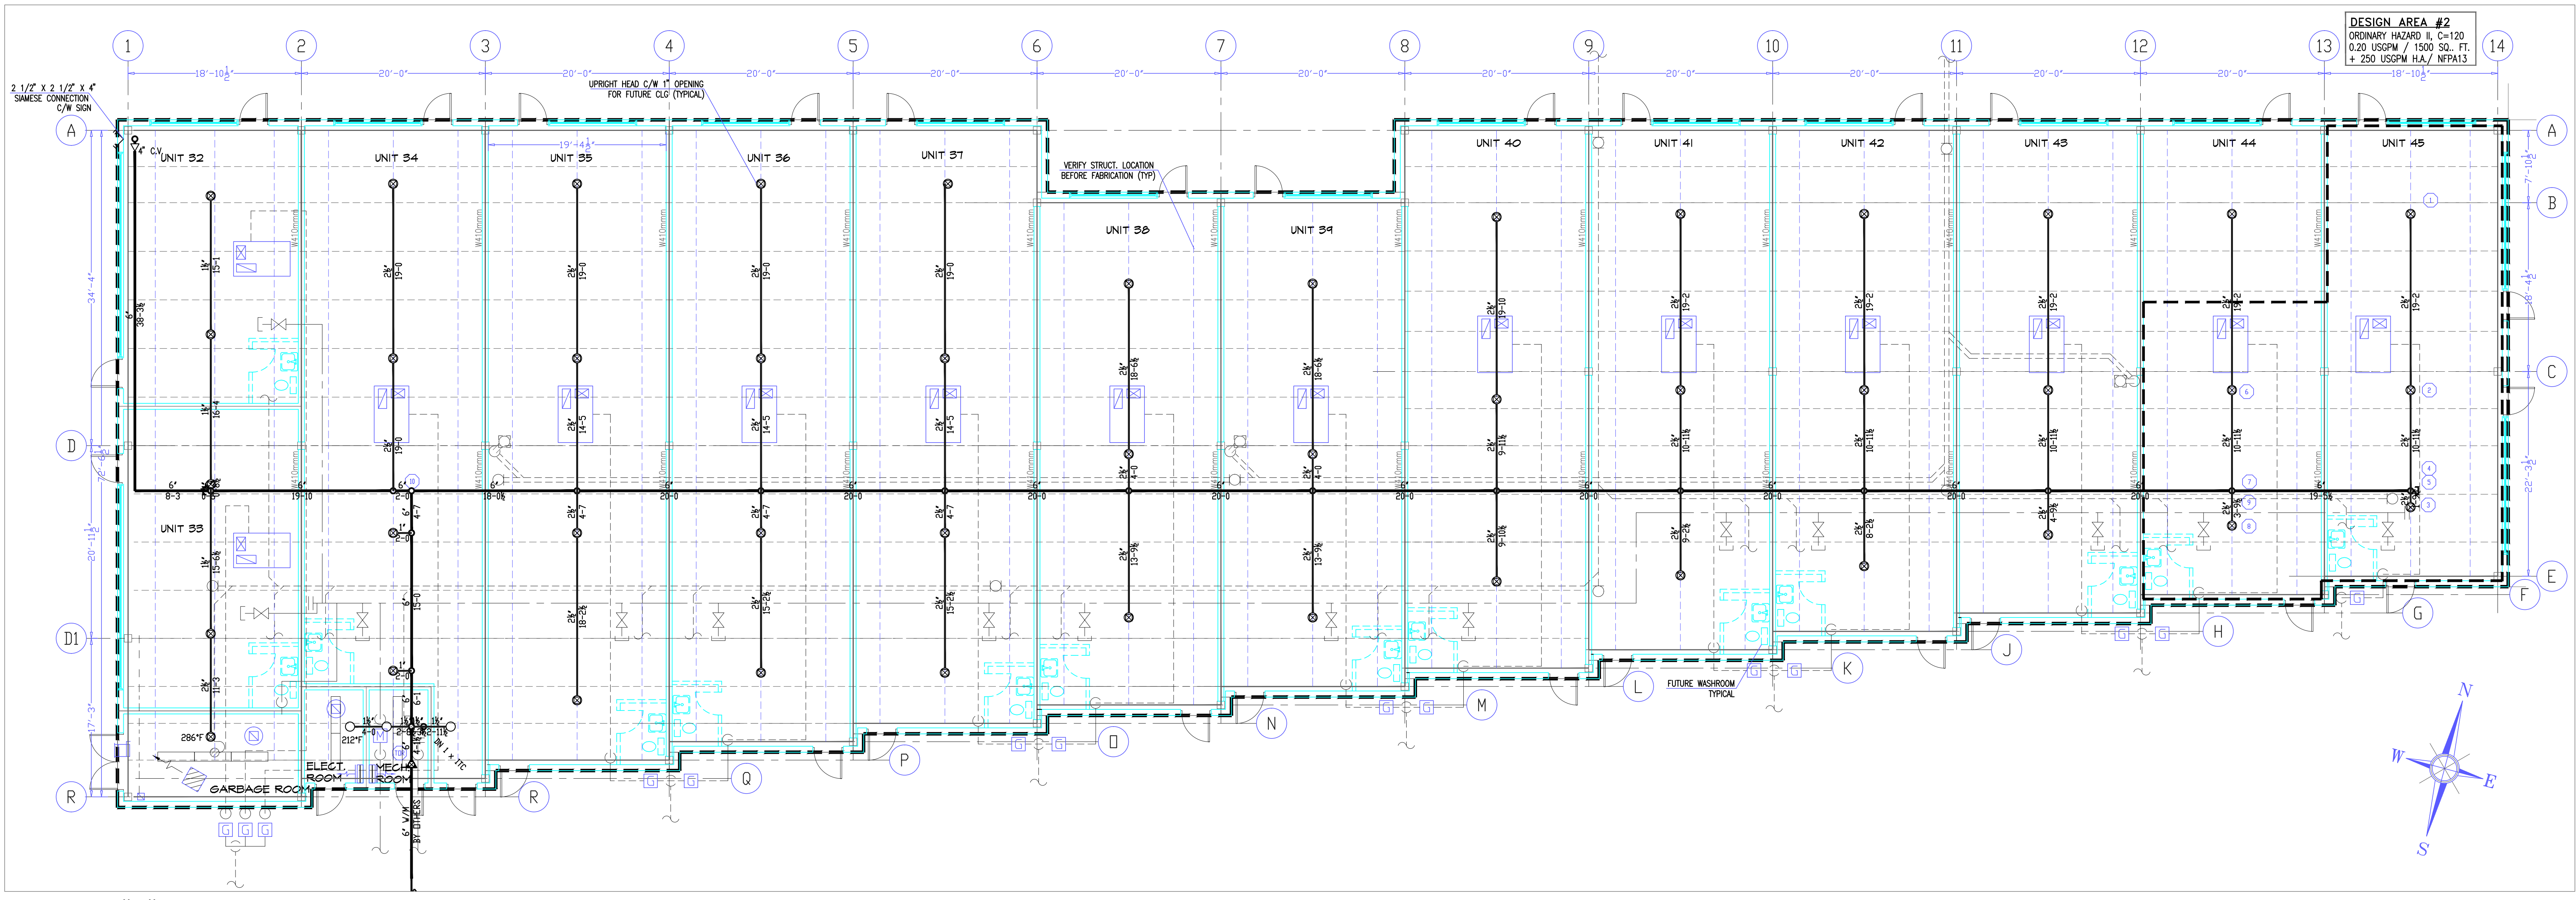


BUILDING "C" - FIRE PROTECTION
Scale: 1/8"=1'-0"

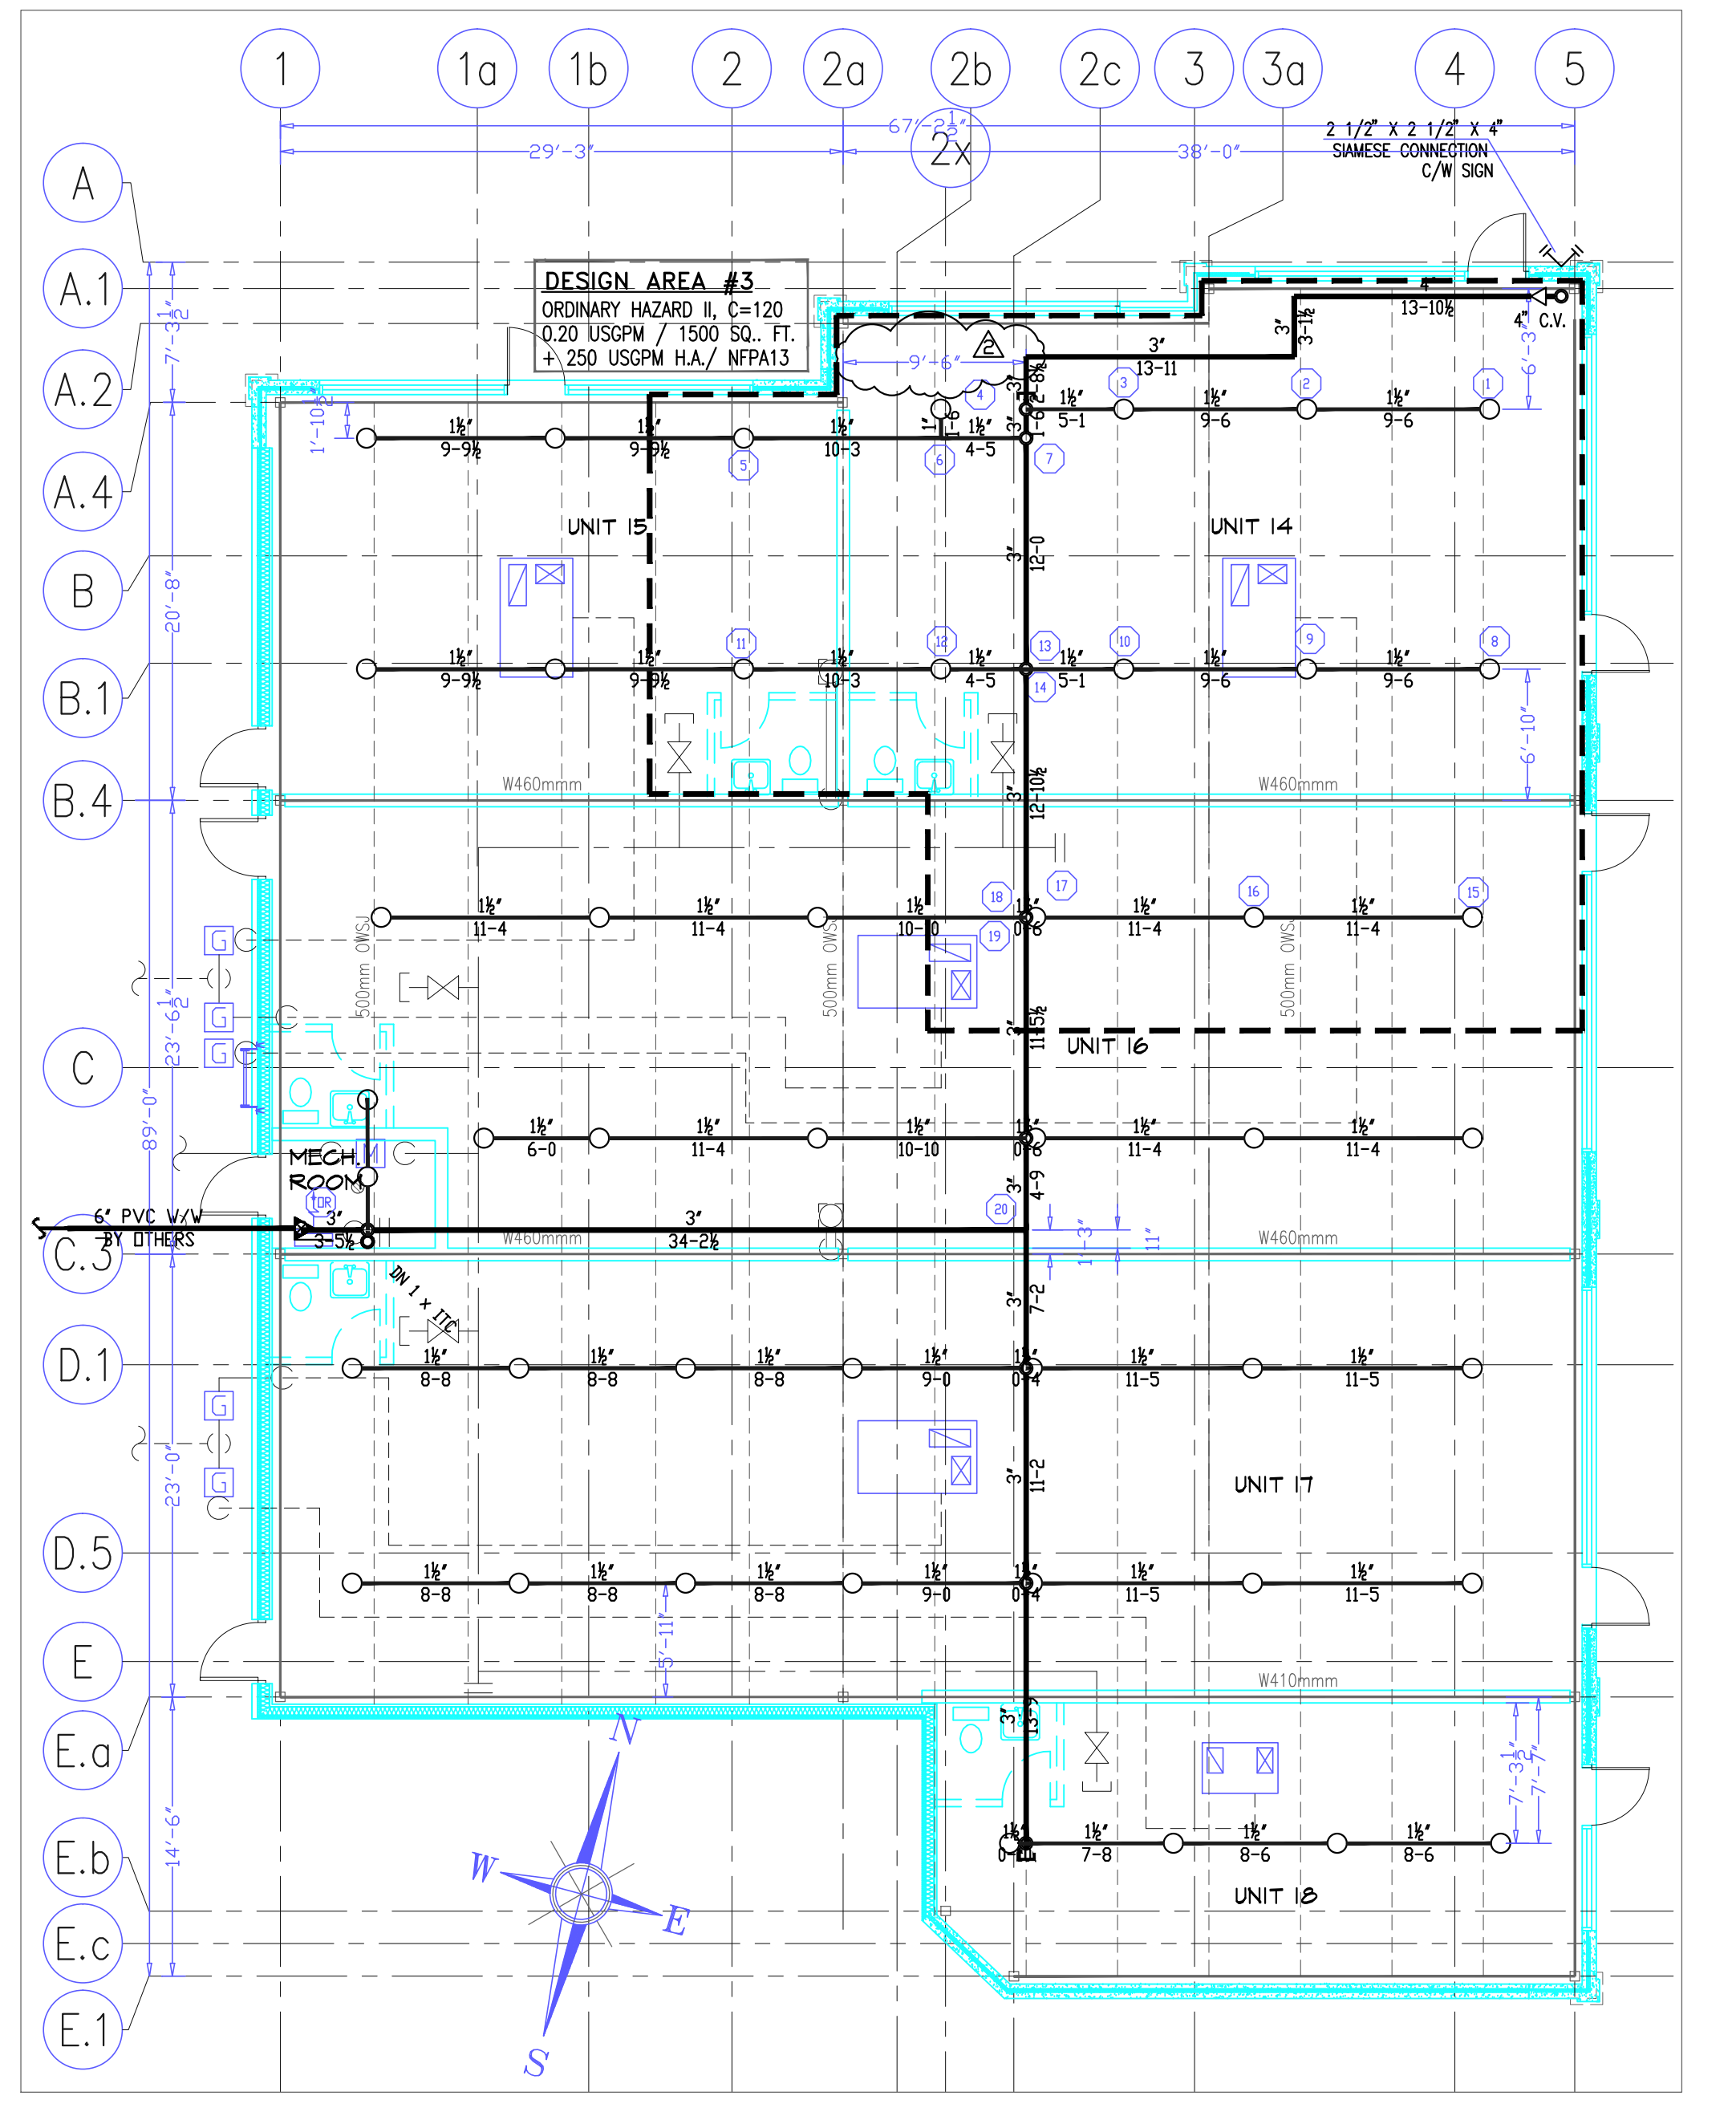

BUILDING "D" - FIRE PROTECTION
Scale: 1/8"=1'-0"

NOTE: - NO FIRE EXTINGUISHERS AND FIRE HOSE CABINETS (TYPICAL FOR BUILDING "B", "C", "D")

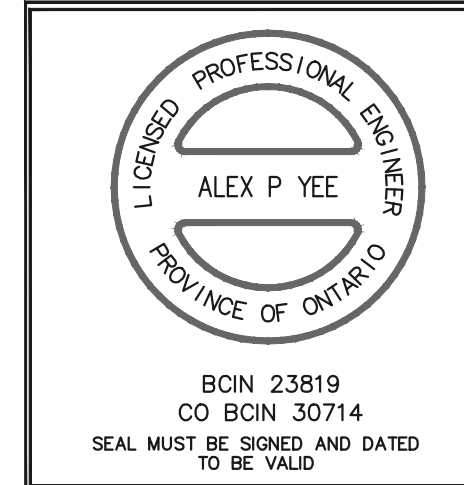

CALCULATION #		CALCULATION #		CALCULATION #	
Hazard Class:					
System Type:					
Density:	GPM/FT ²	GPM/FT ²	GPM/FT ²	GPM/FT ²	GPM/FT ²
Area per Sprinkler:					
Demand:	GPM@ PSI	GPM@ PSI	GPM@ PSI	GPM@ PSI	GPM@ PSI
Flow Test Info:	Firepump:	GPM@ PSI	Date:	Time:	Test By:
Location:	Office Size:	No. of Outlet:	Pilot Press. PSI:	Static PSI:	Residual PSI:
				Flow GPM:	U/G Pipe:
					SAFETY PSI:

REVISION		DATE
1	ISSUED FOR PERMIT	OCT. 08
2	REVISED AS PER SITE CONDITIONS	APR. 09
3	AS BUILT	MAY 10

IMPORTANT
TO PREVENT FREEZING OF WATER IN WET PIPE SPRINKLER PIPING, OWNERS TO PROVIDE SUFFICIENT HEAT THROUGHOUT AREAS WHERE SPRINKLER PIPES ARE INSTALLED, UNLESS AN ANTI-FREEZE SYSTEM.

SPRINKLER SCHEDULE & LEGEND		OFFICE SIZE	TEMP.	FRYSD.	EXT.
⊙	UPRIFT, EC	3/4"	14	150	BRASS 45
⊙	UPRIFT, OR	1/2"	5.8	150	BRASS 2
⊙	UPRIFT	1/2"	5.8	150	BRASS 172

HEAD CABT & WRENCH(ES) PROVIDED TOTAL COUNT THIS SHEET = 219
FireCad Design Software

BRAMPTON BUSINESS CENTRE
5/15/25/35 GUELPH RD, BRAMPTON, ONTARIO

BUILDINGS "B", "C" & "D" - FIRE PROTECTION

General Sprinklers Inc.

315 Deerpark Crescent, Unit 3, Weston, Ontario M9M 2Z2
PHONE (416) 748-1175 FAX (416) 748-1548

DESIGNER	MT
SCALE	AS SHOWN
CHECK BY	AMC
FILE NUMBER	DB-100
APPROVAL	BD
DATE	SEPT. 08
DRAWING NO.	SP4/4